





ALL RIGHTS RESERVED. NO PORTION OF THIS PUBLICATION, WHETHER IN WHOLE OR IN PART, CAN BE REPRODUCED WITHOUT THE EXPRESS WRITTEN CONSENT OF SPC TECHNOLOGY.

SPC-F-005.DWG

REVISIONS				DOC. NO. SPC-F-005 * Effective 7/8/02 * DCP No. 1398			
DCP #	REV	DESCRIPTION		DRAWN	DATE	CHECKD	DATE
XX	XX	XXXX		XXXX	29-09-08	XXXX	29-09-08
XXXX	XXXX			XXXX	29-09-08	XXXX	29-09-08

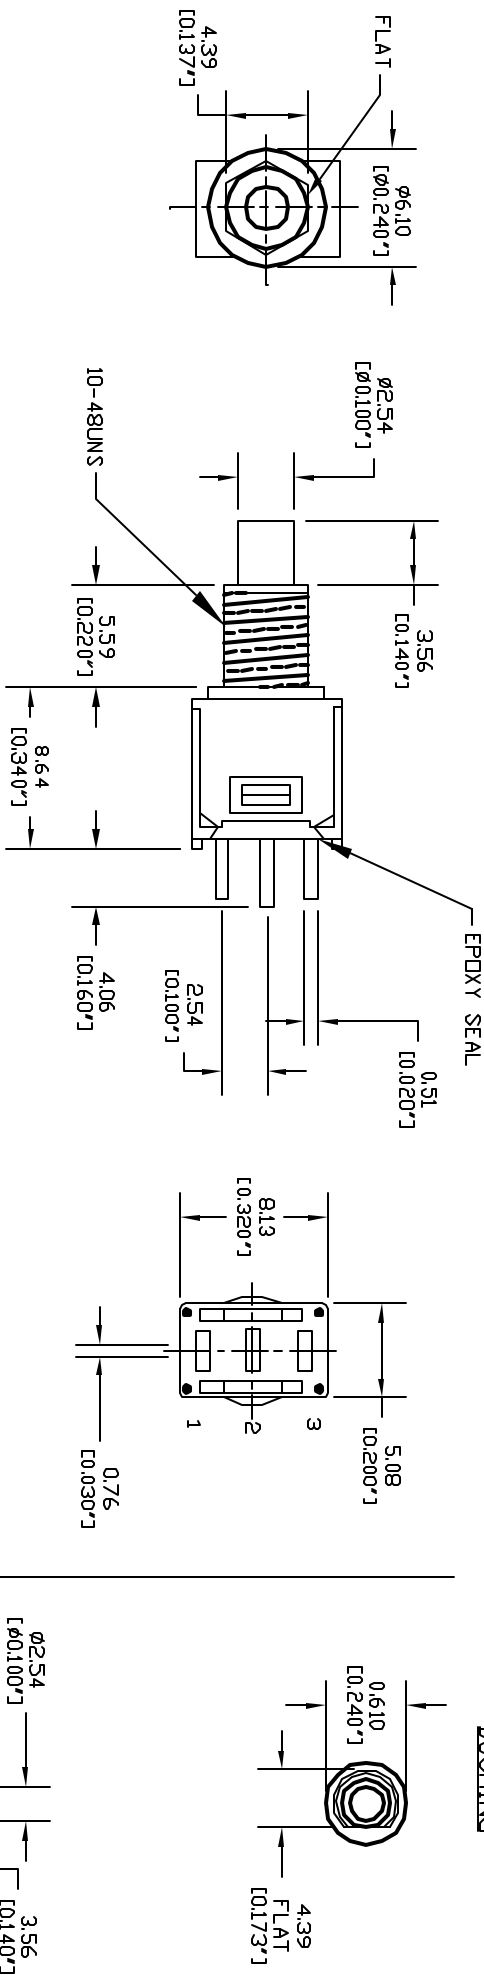

MODEL NO.	SWITCHING POSITION	
	DN	MDM
SPC21204	DN	MDM
CDN. TERMS	2-1	2-3
SCHEMATIC	SPDT	2 Comm.

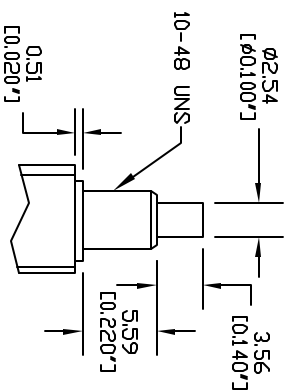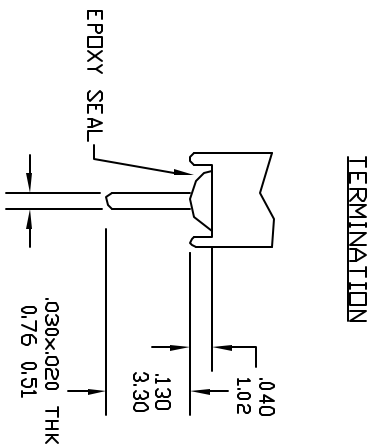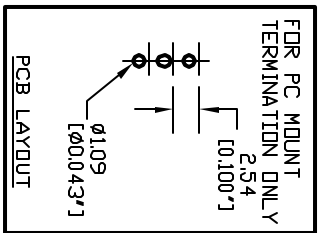

DISCLAIMER: ALL STATEMENTS AND TECHNICAL INFORMATION CONTAINED HEREIN ARE BASED UPON INFORMATION AND/OR TESTS WE BELIEVE TO BE ACCURATE AND RELIABLE. SINCE CONDITIONS OF USE ARE BEYOND OUR CONTROL, THE USER SHALL DETERMINE THE SUITABILITY OF THE PRODUCT FOR THE INTENDED USE AND ASSUME ALL RISK AND LIABILITY WHATSOEVER IN CONNECTION THEREWITH.				TOLERANCES:			
UNLESS OTHERWISE SPECIFIED, DIMENSIONS ARE FOR REFERENCE PURPOSES ONLY.				DRAWN BY:			
XXXX				DATE:			
XXXX				29-09-08			
CHECKED BY:				DATE:			
XXXX				29-09-08			
APPROVED BY:				DATE:			
XXXX				29-09-08			
DRAWING TITLE:				PUSHBUTTON SWITCH			
SIZE DWG. NO. A				SPC21204			
SCALE: NTS				U.D.M. INCHES [MM]			
SHEET: 1 OF 1				ELECTRONIC FILE			
REV				11M0398			
XX				29-09-08			




ALL RIGHTS RESERVED. NO PORTION OF THIS PUBLICATION, WHETHER IN WHOLE OR IN PART, CAN BE REPRODUCED WITHOUT THE EXPRESS WRITTEN CONSENT OF SPC TECHNOLOGY.

SPC-F005.DWG

REVISONS		DDC NO. SPC-F005 * Effective 7/8/02 * DCP No. 1398				
DCP #	REV	DESCRIPTION		DRAWN	DATE	CHECKD
XX	XX	XXXX		XXXX	29-09-08	XXXX
XXXX	XXXX			XXXX	29-09-08	XXXX
				XXXX	29-09-08	XXXX

VERTICAL SUPPORT BRACKET

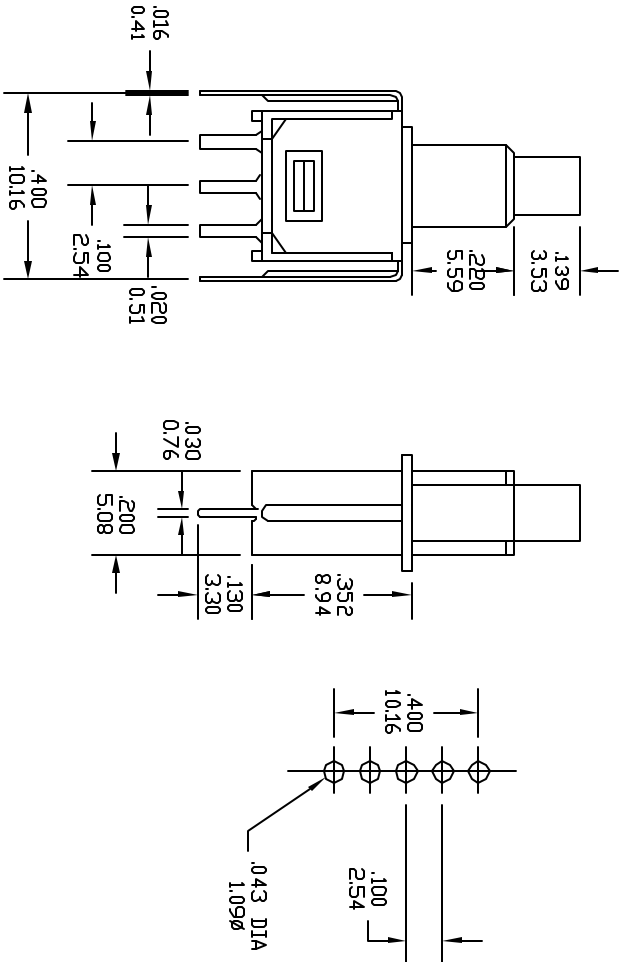

SPECIFICATIONS

<u>ELECTRICAL</u>	
CONTACT RATING:	SILVER, 3A @ 120 VAC OR 28 VDC, 1A @ 250 VAC
	GOLD, 0.4 VA MAX. @ 20 V MAX. (AC OR DC)
CONTACT RESISTANCE:	20 MILLIOHMS MAX.
INSULATION RESISTANCE:	1,000 MEGOHMS MIN. AT 500 VDC
DIELECTRIC STRENGTH:	1,000 VRMS
<u>MECHANICAL</u>	
LIFE:	60,000 CYCLES
<u>ENVIRONMENTAL</u>	
OPERATING TEMPERATURE:	-30°C TO +85°C
<u>MATERIAL</u>	
CASE:	DAP, UL 94V-0
HOUSING:	STAINLESS STEEL
ACTUATOR:	THERMOPLASTIC POLYESTER
BUSHING:	BRASS, NICKEL PLATED
SUPPORT:	BRASS, TIN PLATED
CONTACT/TERMINALS:	COPPER ALLOY, SILVER PLATED
<u>REGULATORY</u>	
UL AND CANADA RECOGNIZED COMPONENT. UL/CUL FILE NO. E173084.	



DISCLAIMER:
ALL STATEMENTS AND TECHNICAL INFORMATION CONTAINED HEREIN ARE BASED UPON INFORMATION AND/OR TESTS WE BELIEVE TO BE ACCURATE AND RELIABLE. SINCE CONDITIONS OF USE ARE BEYOND OUR CONTROL, THE USER SHALL DETERMINE THE SUITABILITY OF THE PRODUCT FOR THE INTENDED USE AND ASSUME ALL RISK AND LIABILITY WHATSOEVER IN CONNECTION THEREWITH.

TOLERANCES:		DRAWING TITLE:	
UNLESS OTHERWISE SPECIFIED, DIMENSIONS ARE FOR REFERENCE PURPOSES ONLY.		DRAWING TITLE:	
DRAWN BY:	DATE:	DRAWING TITLE:	
XXXX	29-09-08	DRAWING TITLE:	
CHECKED BY:	DATE:	DRAWING TITLE:	
XXXX	29-09-08	DRAWING TITLE:	
APPROVED BY:	DATE:	DRAWING TITLE:	
XXXX	29-09-08	DRAWING TITLE:	
SCALE: NTS		U.O.M.: INCHES [mm]	
SHEET: 1 OF		SHEET: 1 OF	

PUSHBUTTON SWITCH

SIZE DWG. NO. SPC21204 ELECTRONIC FILE 11M0398 REV