


REVISIONS				DDC. NO. SPC-FD05, Total Pages: 2			
DCP #	REV	DESCRIPTION	DRAWN	DATE	CHECKD	DATE	APPRVD
09	A	RELEASED	J.W.M.	10/8/97	J.C.	10/24/97	B.B.
421	B	Electronic file name change	J.W.M.	2/5/98	J.C.	2/5/98	J.C.

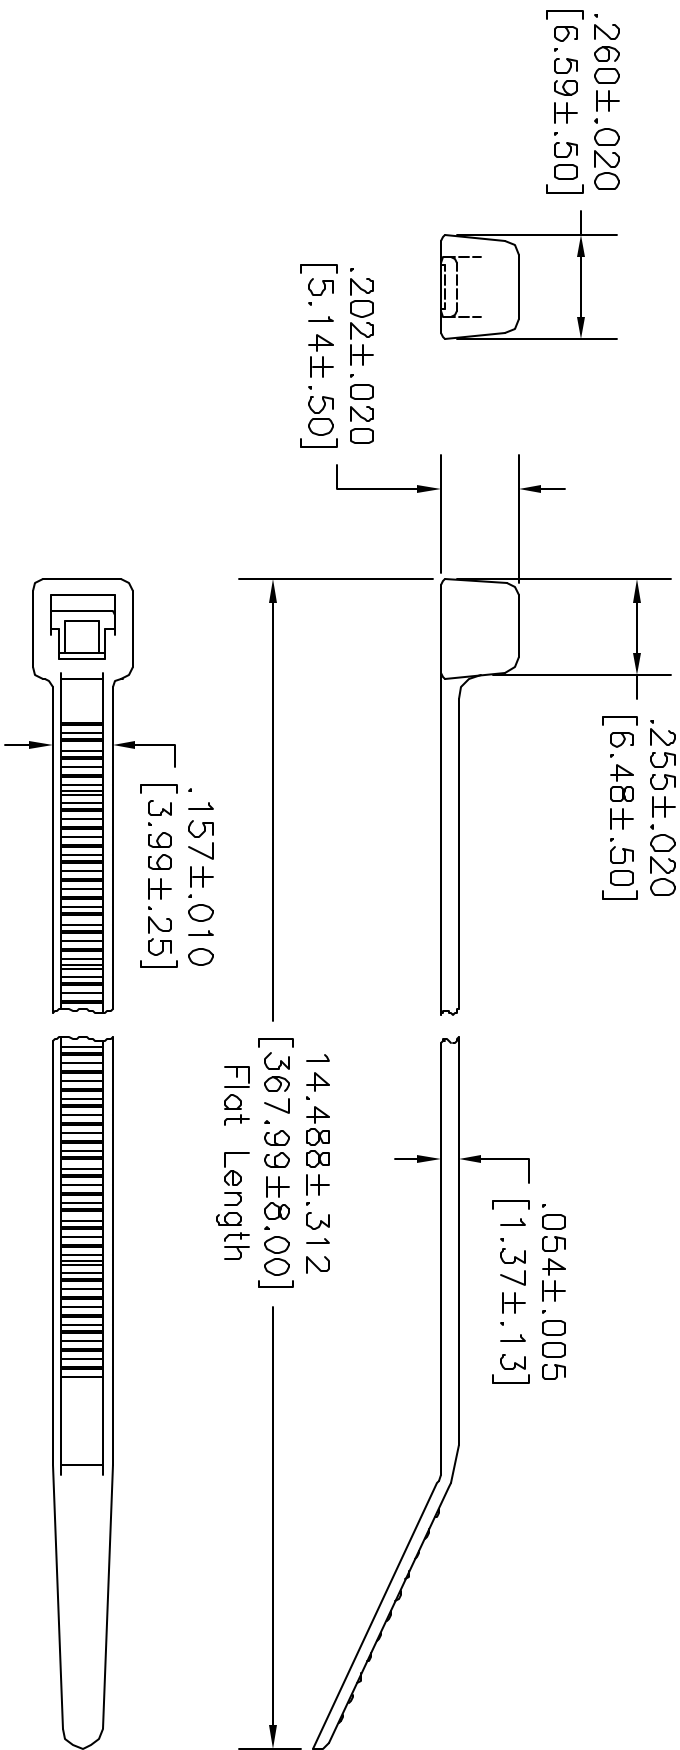

NOTES:
Material: Nylon 6/6-HSO
Color: Black
Packed: 100 to Bag
Max. Bundle Dia: 4.00 [101.6]
Min. Bundle Dia: .063 [1.59]
Min. Loop Tensile Strength: 40lbs.

DISCLAIMER
ALL STATEMENTS AND TECHNICAL INFORMATION CONTAINED HEREIN ARE BASED UPON INFORMATION AND/OR TESTS WE BELIEVE TO BE ACCURATE AND RELIABLE. SPC TECHNOLOGY OF LEE, ARIZONA, AND/OR ITS SUBSIDIARIES SHALL NOT BE RESPONSIBLE FOR ANY DAMAGE, LOSS, OR INJURY THAT MAY BE SUSTAINED BY ANY USER OF THIS PRODUCT FOR THE INTENDED USE AND ASSURE ALL RISK AND LIABILITY WHATSOEVER IN CONNECTION THEREWITH.

Unless Otherwise Specified,
Dimensions are shown for
reference only! Your own
tests will determine the
suitability of this product
for your application.

DRAWING TITLE:				DRAWING NO.			
DRAWN BY:	DATE:	CHECKED BY:	DATE:	SIZE	DWG. NO.	ELECTRONIC FILE	REV
Jeff McVicker	10/8/97	JOHN COLE	10/24/97	A	8409-0387	16N877.dwg	B
APPROVED BY:	DATE:	SCALE:	NTS	U.O.M.: INCHES [mm]	SHEET:	1	OF 1
BRETT BRAATZ	11/4/97						



Cable Tie - Heat Stabilized