


ROHS-COMPLIANT

LTR	REV.	DESCRIPTION	DATE

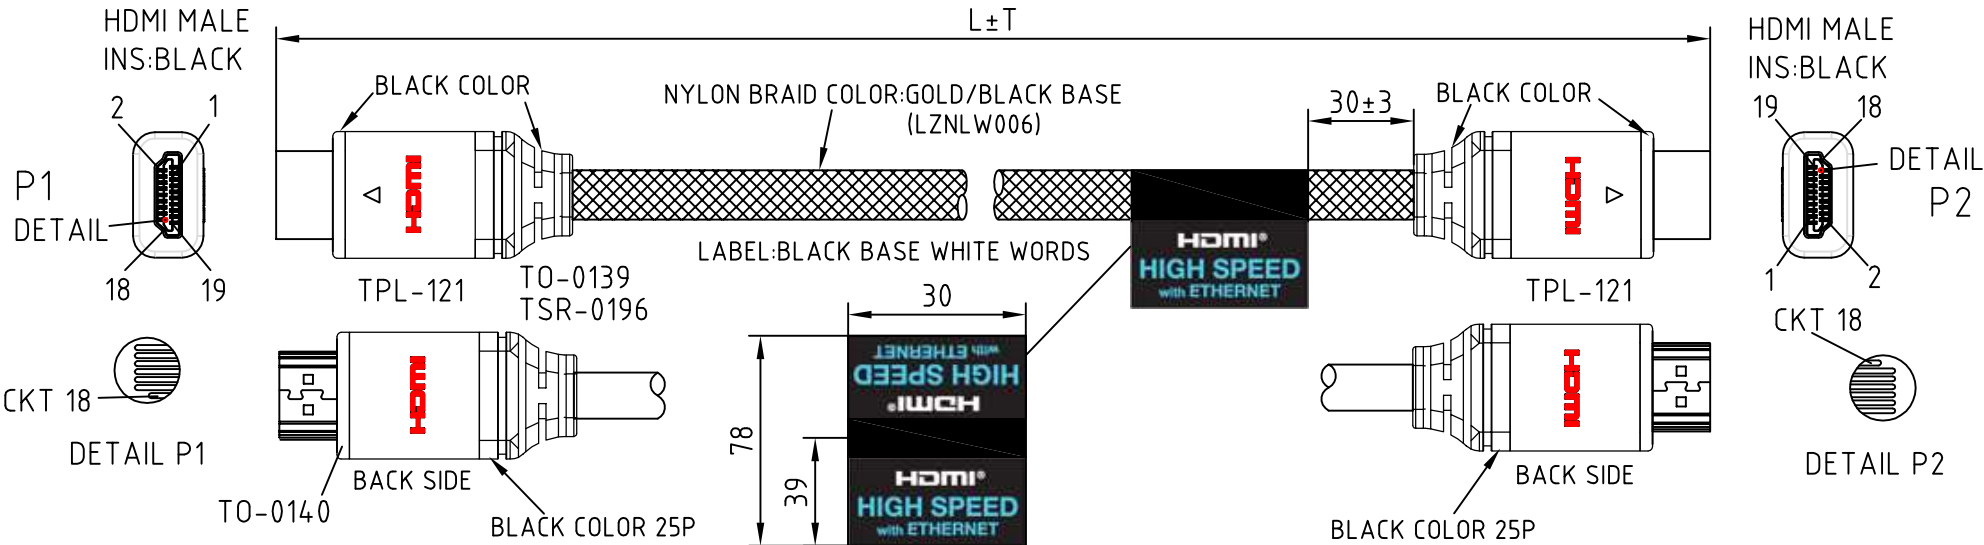

HDMI	PIN OUT	HDMI
P1		P2 CABLE FUNCTION
1		1 TMDS DATA 2+
3		3 TMDS DATA 2-
2		2 TMDS DATA 2 SHIELD
4		4 TMDS DATA 1+
6		6 TMDS DATA 1-
5		5 TMDS DATA 1 SHIELD
7		7 TMDS DATA 0+
9		9 TMDS DATA 0-
8		8 TMDS DATA 0 SHIELD
10		10 TMDS CLOCK +
12		12 TMDS CLOCK -
11		11 TMDS CLOCK SHIELD
14		14 UTILITY/HEAC+
19		19 HOT PLUG DETECT/HEAC-
17		17 DDC/CEC GROUND/HEAC SHIELD
13		13 CEC
15		15 SCL
16		16 SDA
18		18 +5V POWER
SHELL	B.D	SHELL GROUND

- NOTE:
- 1.CABLE: UL-20276 [#30(7/0.1 T.C)×1P INS:FOAM-PE+D.W(7/0.1 T.C)+AL/MY+MY]×5C+#30(7/0.1 T.C)×4C INS:Polyolefin+AL/MY+B.D(85%) PVC JACKET OD:6.5±0.15mm COLOR:BLACK(NK-K01) CABLE MUST PRINTED: High Speed HDMI™ Cable with Ethernet
 - 2.CONNECTOR: P1&P2: HDMI 19P MALE CONTACT:15u"; GOLD FLASH(1.8u") SHELL.
 - 3.HOOD: P1&P2:ASS'Y TYPE, ALUMINUM HOOD GOLD PLATED SR:MOLDED TYPE,PVC 45P,COLOR:BLACK(NK-K01) .
 - 4.ELECTRICAL TEST: (1)100% OPEN SHORT & MIS WIRE TEST. (2)CONTACT RESISTANCE 3 ohm Max . (3)INSULATION RESISTANCE 10M ohm Min .
 - 5.PACKING: EACH PC/POLYBAG+BIG HEADER CARD+BARCODE LABEL.

Tolerance Inch M/M				Rotronic co., LTD.			
. X	.015	.30					
. XX	.010	.10					
. XXX	.005	.05					
Draw				Title			
FANNIE 10/12/10'				High Speed HDMI Cable with Ethernet			
Chek				Customer P/N:			
Engr				App'd		Customer: T-RAG	
DWG		P/N	L±T(mm)	Scale	NONE	Units	M/M
200-1455-4		11.04.5505	5000±50	10			
200-1455-3		11.04.5503	3000±30	20			
200-1455-2		11.04.5502	2000±30	20			
200-1455-1		11.04.5501	1000±20	20			
				Dwg No. 200-1455		REV:A	
				Sheet.1/1			